

**liquid design**

www.liquid-design.me.uk  
 info@liquid-design.me.uk  
 01604 882506

Notes;

*Do not scale from this drawing.*

*All measurements to be checked on site.*


*The details shown on this drawing are for approval purposes.*

*This Drawing must be signed approved and accepted as correct by the client before the project progresses.*

Copyright © 2006 Liquid Design. All rights are reserved.

date	description	initial

STATUS	PRELIMINARY	DRAWING TITLE	<i>Existing</i>
CLIENT		DATE	05 / 04 / 2006
PROJECT	Bathroom REFURBISHMENT	SCALE	1:20 AT A3
		DRAWING NUMBER	<b>LD0 /DB/001.0</b>

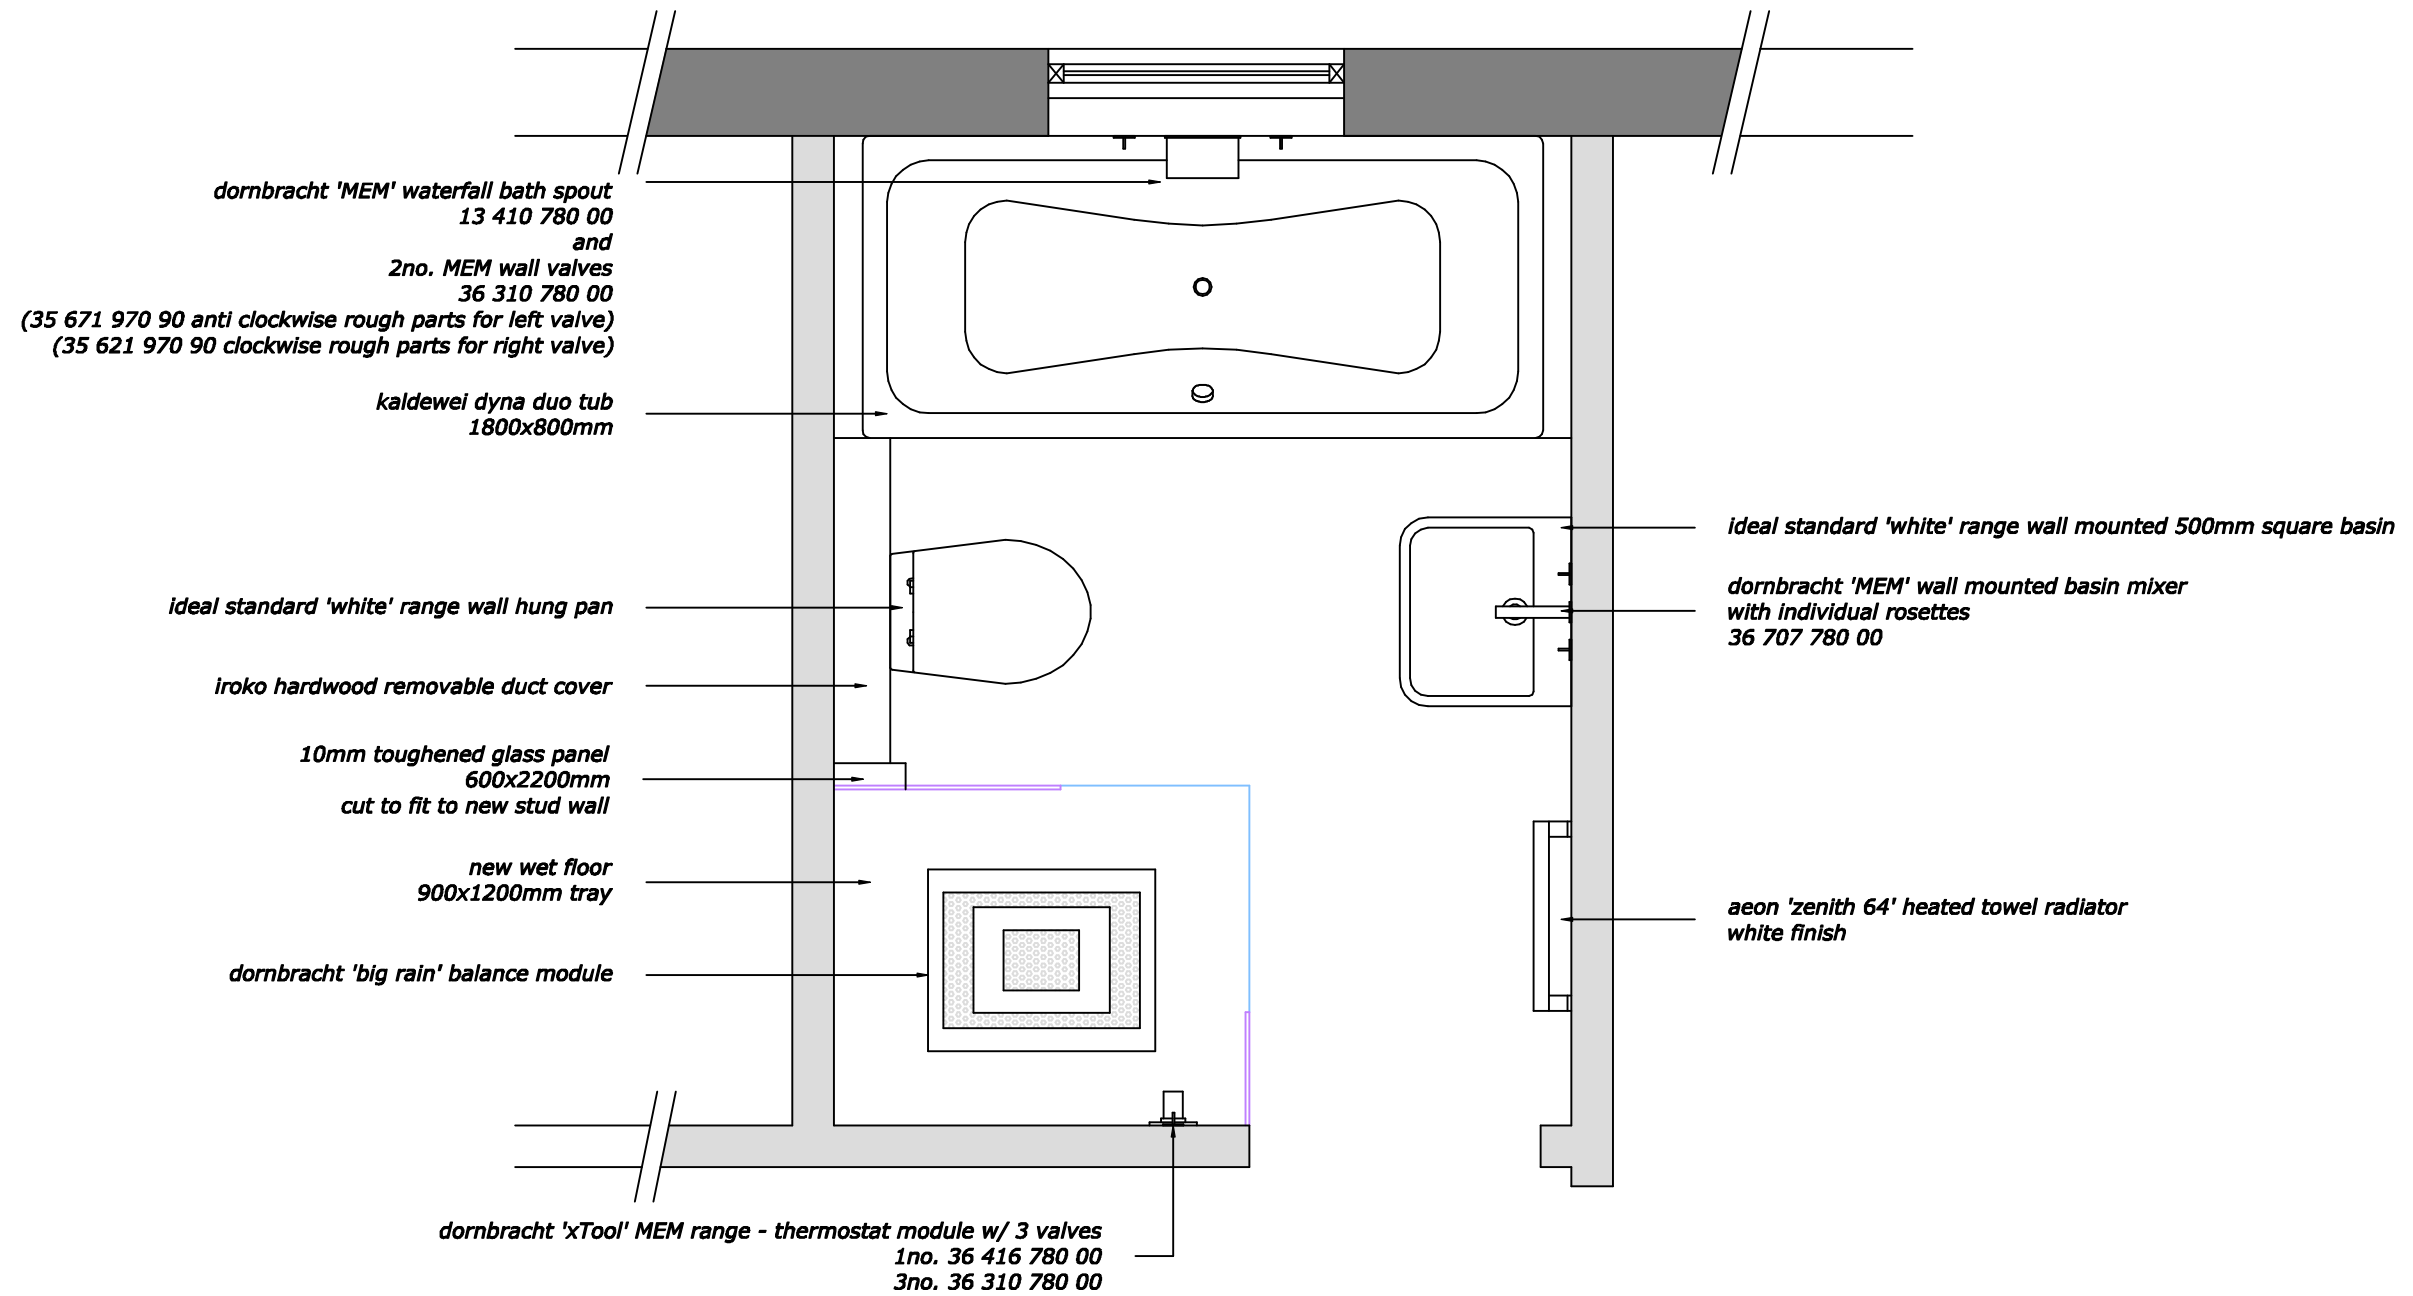

**liquid design**

[www.liquid-design.me.uk](http://www.liquid-design.me.uk)  
[info@liquid-design.me.uk](mailto:info@liquid-design.me.uk)  
 01604 882506

Notes;

*Do not scale from this drawing.*


*All measurements to be checked on site.*

*The details shown on this drawing are for approval purposes.*

*This Drawing must be signed approved and accepted as correct by the client before the project progresses.*

Copyright © 2006 Liquid Design. All rights are reserved.

<table border="1"> <tr> <td>date</td> <td>description</td> <td>initial</td> </tr> <tr> <td> </td> <td> </td> <td> </td> </tr> <tr> <td> </td> <td> </td> <td> </td> </tr> </table>	date	description	initial							STATUS	PRELIMINARY	DRAWING TITLE	Proposed Equipment
	date	description	initial										
CLIENT		DATE	05 / 04 / 2006	SCALE 1:20 AT A3									
PROJECT	Bathroom REFURBISHMENT	DRAWING NUMBER	LDO /DB/002.0										

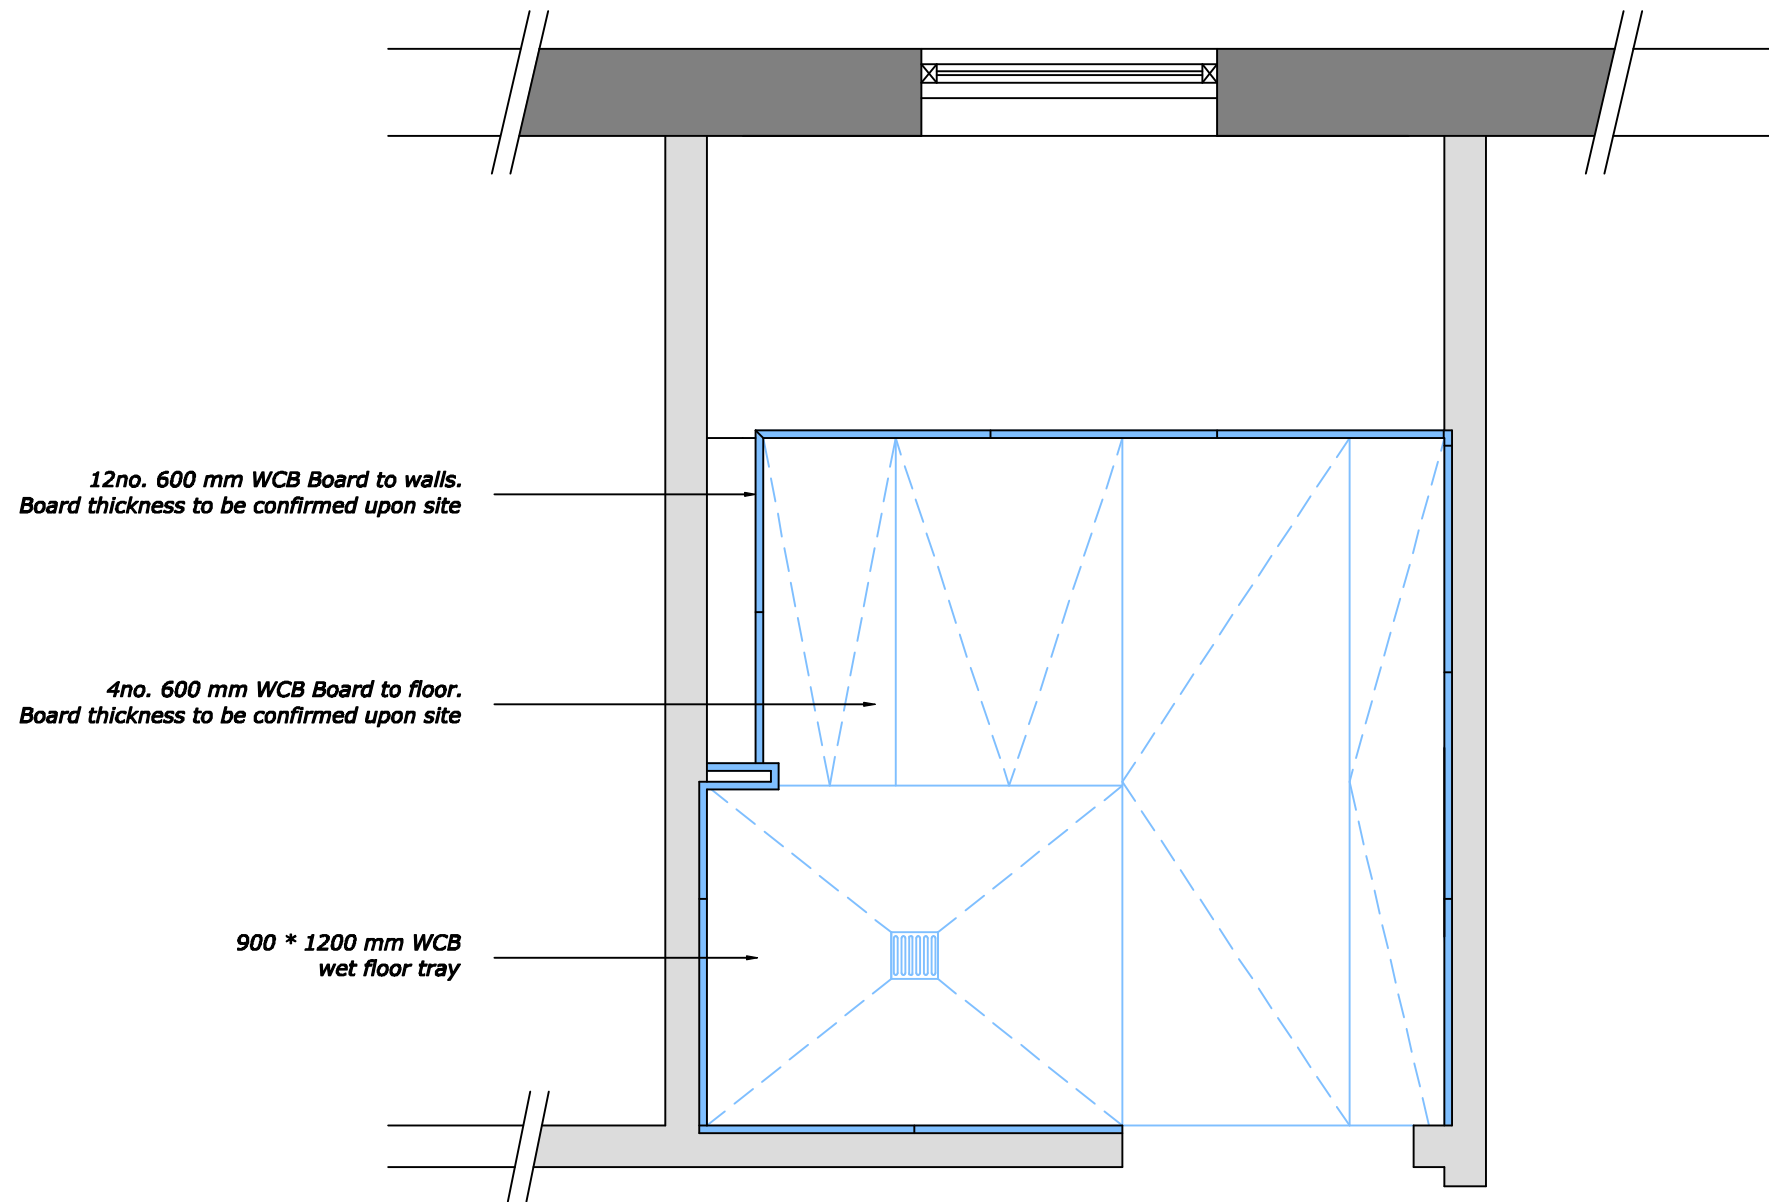

12no. 600 mm WCB Board to walls.  
Board thickness to be confirmed upon site

4no. 600 mm WCB Board to floor.  
Board thickness to be confirmed upon site

900 \* 1200 mm WCB  
wet floor tray

**liquid design**

www.liquid-design.me.uk  
info@liquid-design.me.uk  
01604 882506

Notes;

*Do not scale from this drawing.*


*All measurements to be checked on site.*

*The details shown on this drawing are for approval purposes.*

*This Drawing must be signed approved and accepted as correct by the client before the project progresses.*

Copyright © 2006 Liquid Design. All rights are reserved.

date	description	initial	STATUS	PRELIMINARY	DRAWING TITLE	Proposed Wet Floor Layout
			CLIENT		DATE	05 / 04 / 2006
			PROJECT	Bathroom REFURBISHMENT	SCALE	1:20 AT A3
					DRAWING NUMBER	<b>LDO /RK/003.0</b>

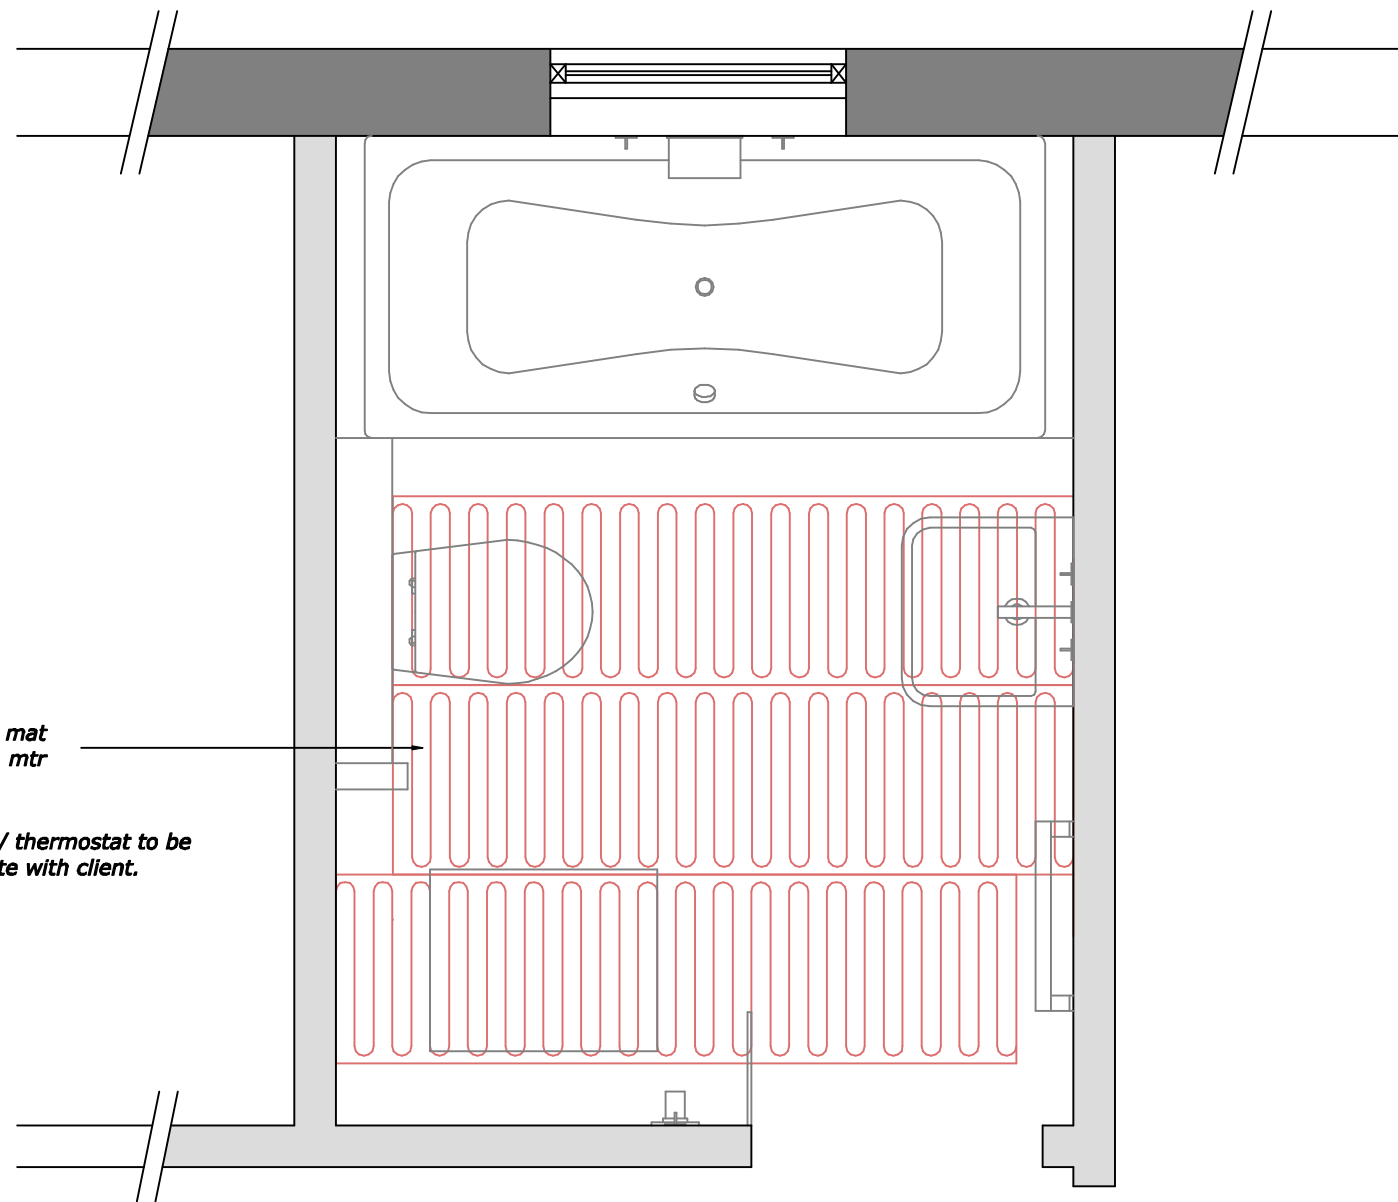

6.00 lin. mtr. mat  
150w per sq. mtr

Location of timer / thermostat to be  
discussed upon site with client.

**liquid design**

www.liquid-design.me.uk  
info@liquid-design.me.uk  
01604 882506

Notes;

*Do not scale from this drawing.*

*All measurements to be checked on site.*

*The details shown on this drawing are for approval purposes.*

*This Drawing must be signed approved and accepted as correct by the client before the project progresses.*

Copyright © 2006 Liquid Design. All rights are reserved.

date	description	initial

STATUS	PRELIMINARY	DRAWING TITLE	<i>Underfloor Heating Layout</i>
CLIENT		DATE	05 / 04 / 2006
PROJECT	Bathroom REFURBISHMENT	SCALE	1:20 AT A3
		DRAWING NUMBER	<b>LD0 /DB/004.0</b>


**Zone Key**

**Zone 0**  
All light fittings in zone 0 must be watertight and be 12 volts or less. (IP67 or IPX7).

**Zone 1**  
All light fittings in zone 1 must be splash proof (IP44 or IPX4).  
Please note: mains voltage fittings in this zone must be wired on a separate circuit and protected by a 30mA residual current device (RCD).

**Zone 2**  
All light fittings in zone 2 must be splashproof (IP44 or IPX4).

**Zone 3**  
All light fittings in zone 3 have no special requirements.

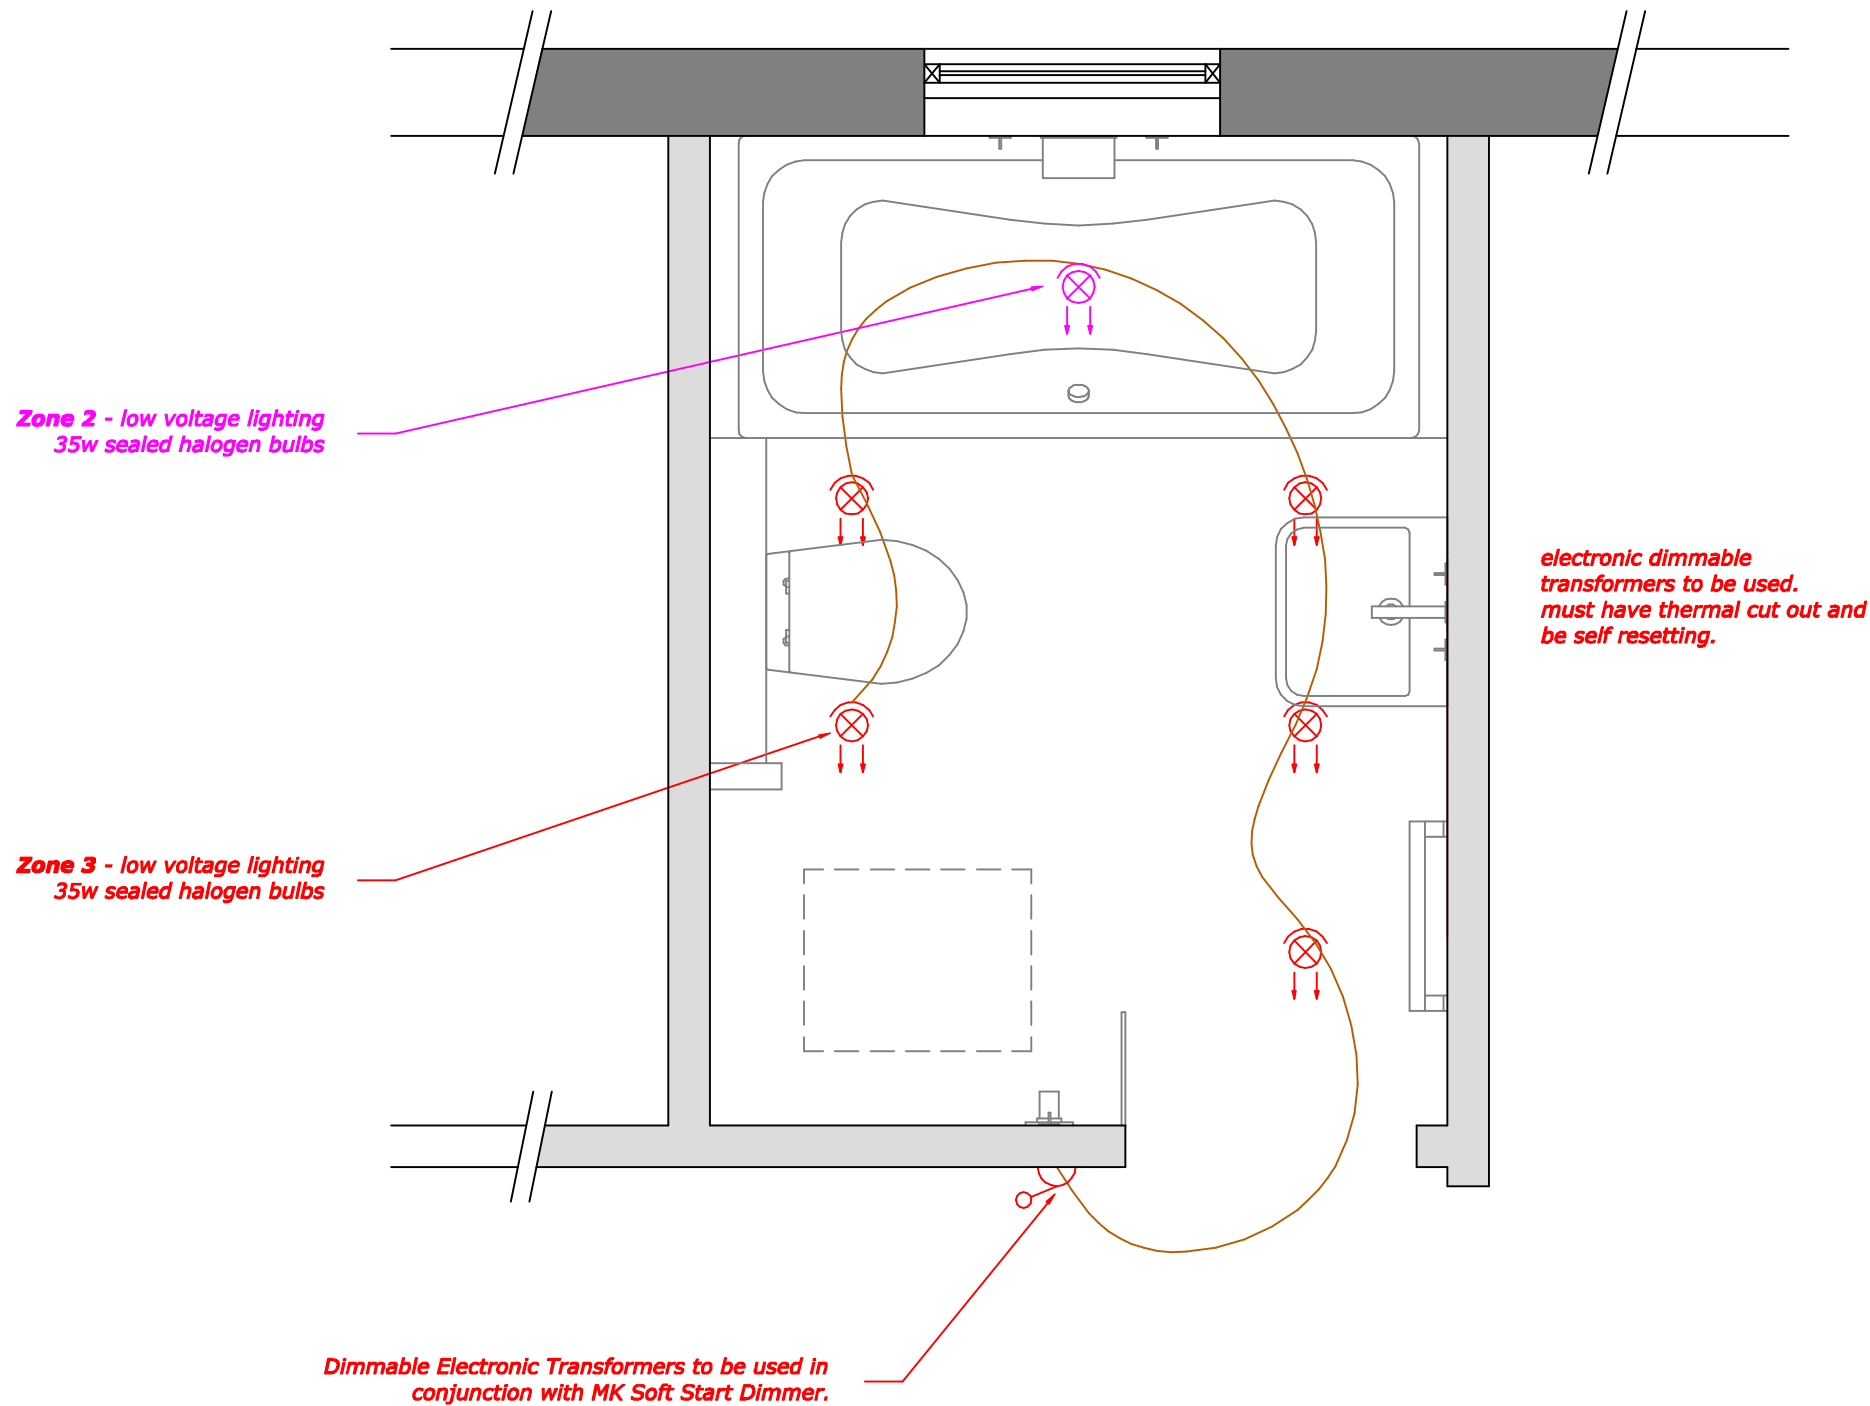

**liquid design**

www.liquid-design.me.uk  
info@liquid-design.me.uk  
01604 882506

Notes;

*Do not scale from this drawing.*


*All measurements to be checked on site.*

*The details shown on this drawing are for approval purposes.*

*This Drawing must be signed approved and accepted as correct by the client before the project progresses.*

Copyright © 2006 Liquid Design. All rights are reserved.

<table border="1"> <tr> <td>04.04.06</td> <td>checked / altered</td> <td>RK</td> </tr> <tr> <td>date</td> <td>description</td> <td>initial</td> </tr> </table>	04.04.06	checked / altered	RK	date	description	initial	STATUS	PRELIMINARY	DRAWING TITLE	Proposed Lighting Plan
	04.04.06	checked / altered	RK							
	date	description	initial							
CLIENT		DATE	05 / 04 / 2006							
PROJECT	Bathroom REFURBISHMENT	SCALE	1:20 AT A3	DRAWING NUMBER						
				<b>LDO /RK/005.0</b>						

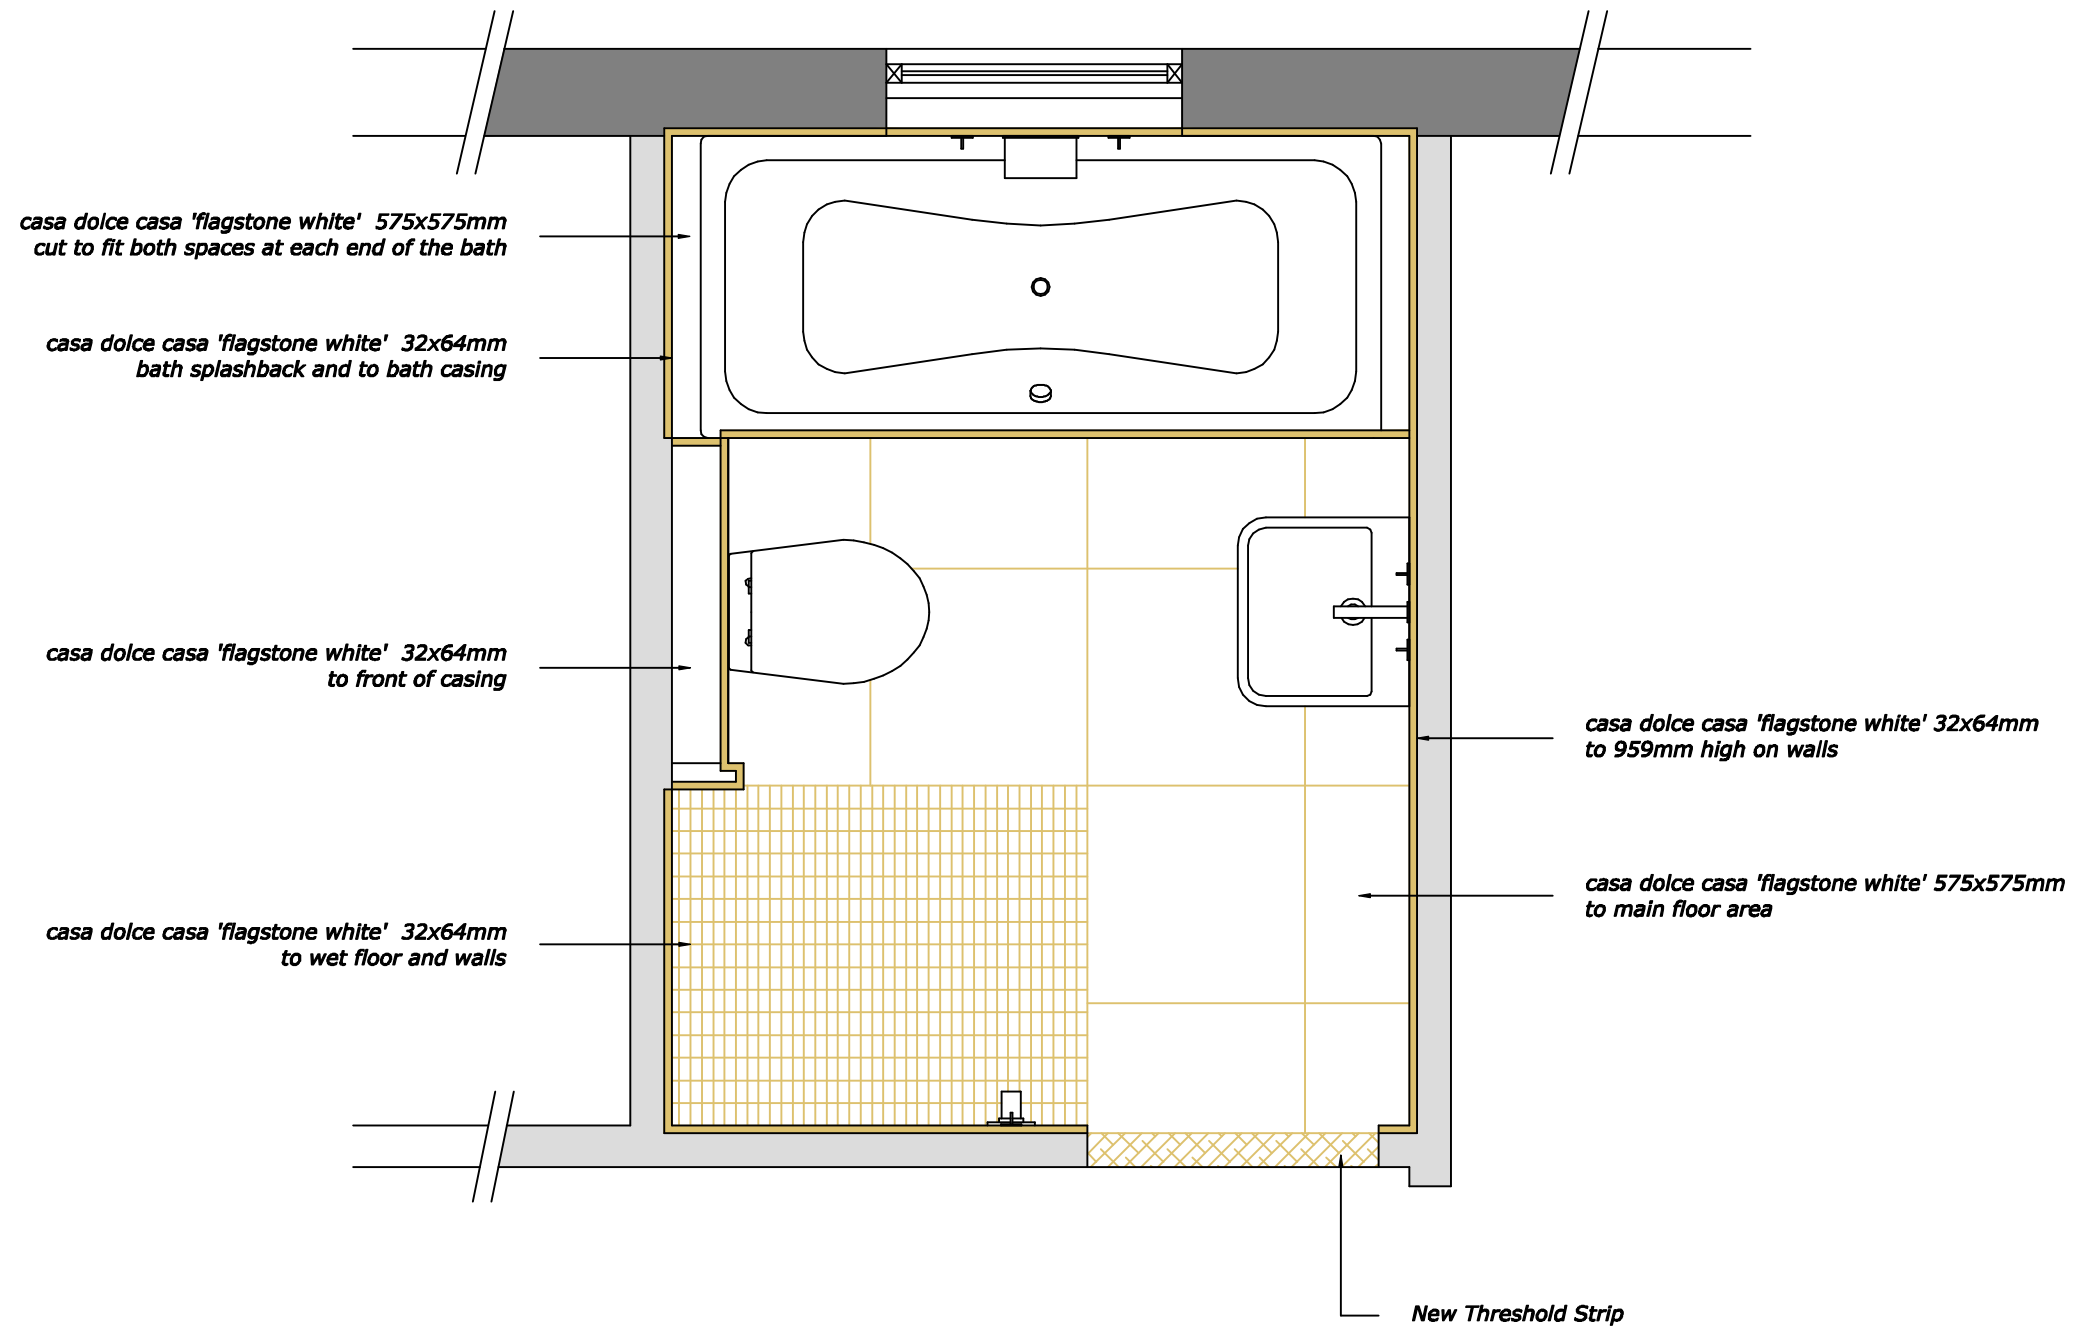

**liquid design**

www.liquid-design.me.uk  
 info@liquid-design.me.uk  
 01604 882506

Notes;

*Do not scale from this drawing.*


*All measurements to be checked on site.*

*The details shown on this drawing are for approval purposes.*

*This Drawing must be signed approved and accepted as correct by the client before the project progresses.*

Copyright © 2006 Liquid Design. All rights are reserved.

			STATUS	PRELIMINARY	DRAWING TITLE	<i>Proposed Tiling Layout</i>
			CLIENT		DATE	05 / 04 / 2006
					SCALE	1:20 AT A3
			PROJECT	Bathroom REFURBISHMENT	DRAWING NUMBER	
04.04.06	checked / altered	RK			<b>LD0</b>	<b>/DB/006.0</b>
date	description	initial				

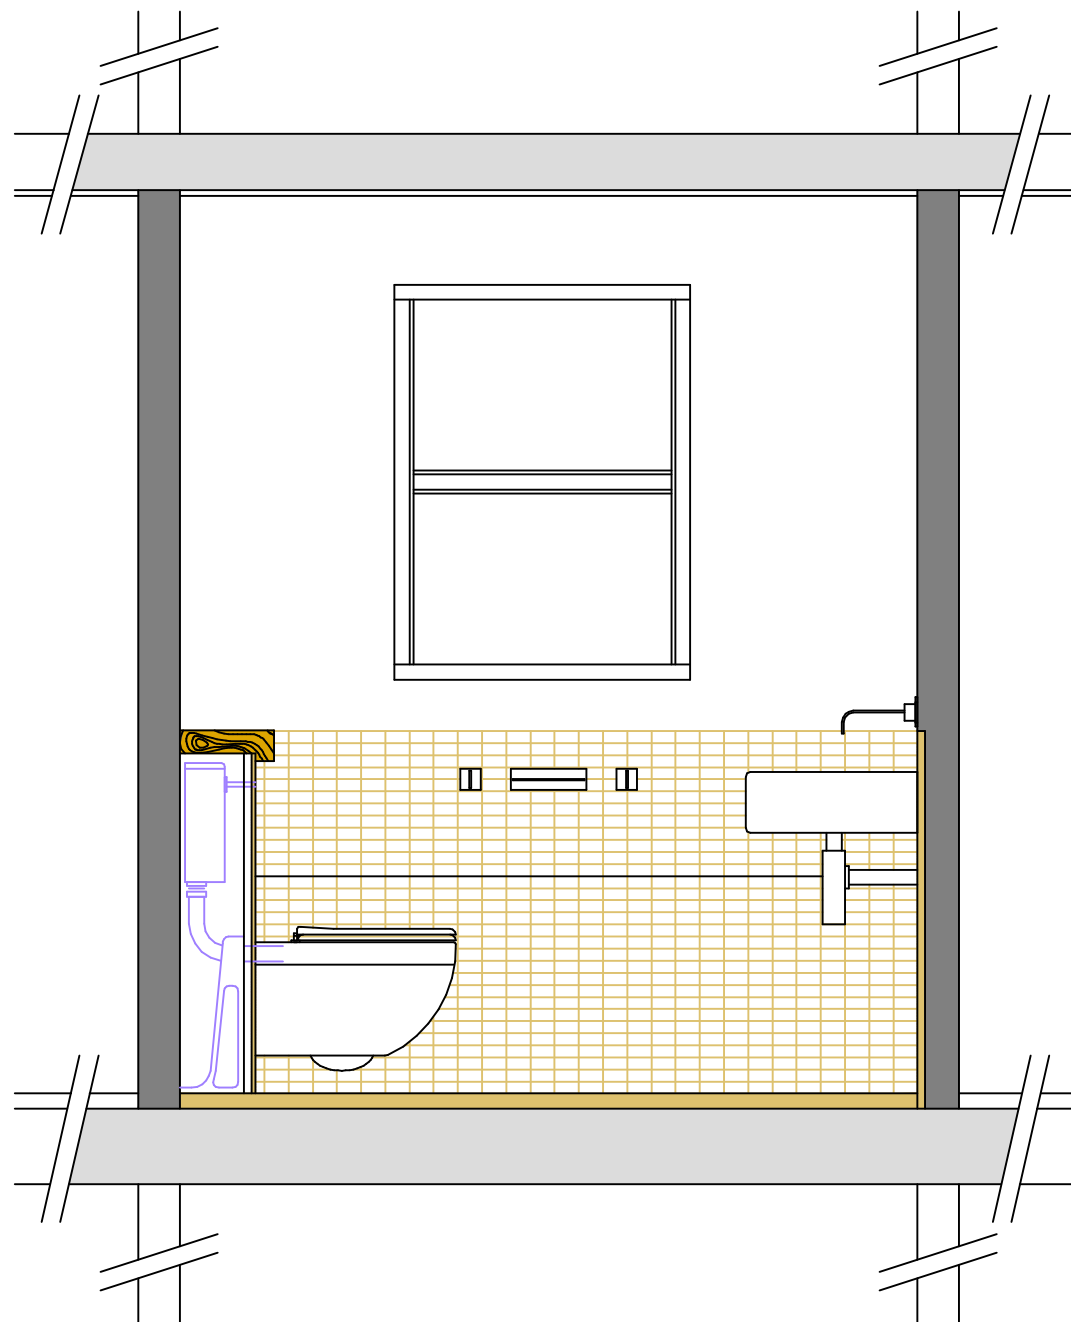

**liquid design**

www.liquid-design.me.uk  
 info@liquid-design.me.uk  
 01604 882506

Notes;

*Do not scale from this drawing.*

*All measurements to be checked on site.*


*The details shown on this drawing are for approval purposes.*

*This Drawing must be signed approved and accepted as correct by the client before the project progresses.*

Copyright © 2006 Liquid Design. All rights are reserved.

date	description	initial

STATUS	PRELIMINARY	DRAWING TITLE	<i>Proposed - Elevation</i>
CLIENT		DATE	05 / 04 / 2006
PROJECT	Bathroom REFURBISHMENT	SCALE	1:20 AT A3
		DRAWING NUMBER	<b>LDO /DB/007.0</b>

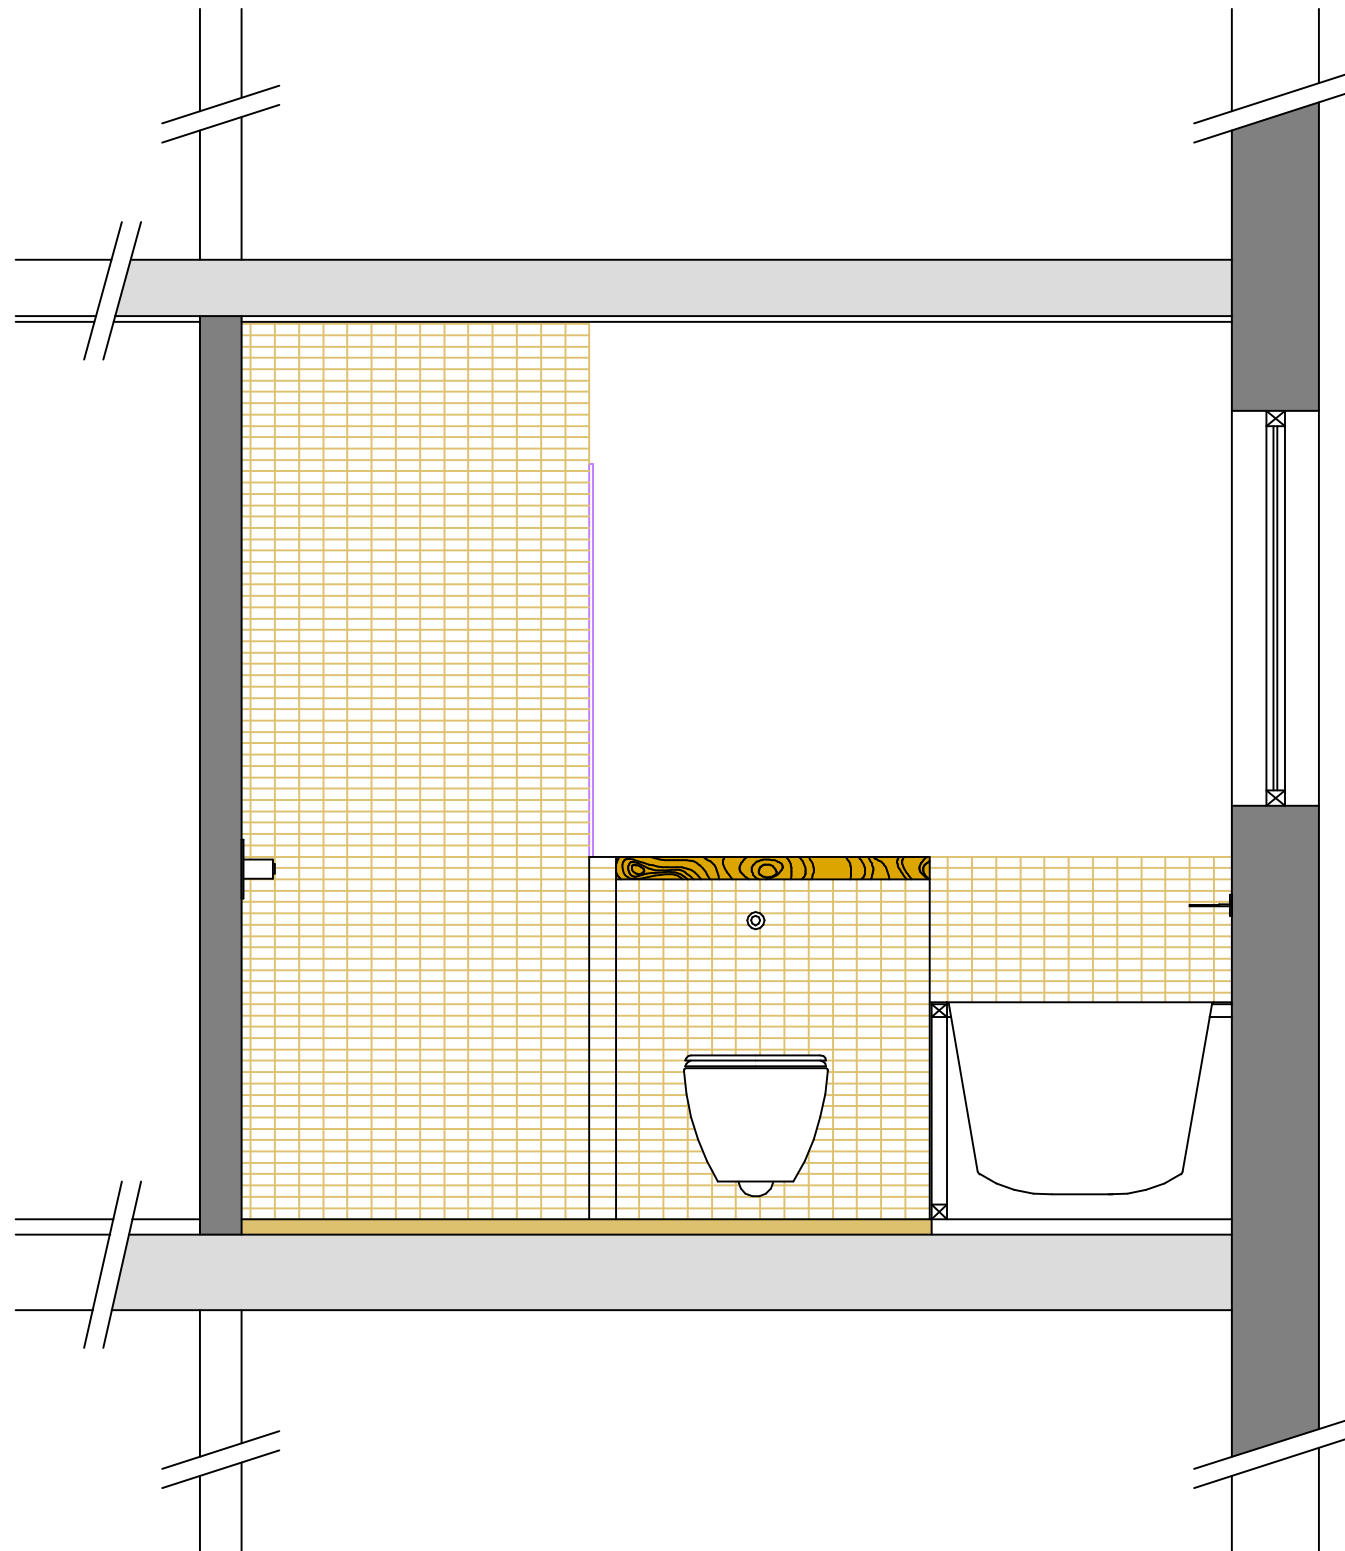

**liquid design**

www.liquid-design.me.uk  
 info@liquid-design.me.uk  
 01604 882506

Notes;

*Do not scale from this drawing.*

*All measurements to be checked on site.*

*The details shown on this drawing are for approval purposes.*

*This Drawing must be signed approved and accepted as correct by the client before the project progresses.*

Copyright © 2006 Liquid Design. All rights are reserved.

			STATUS	PRELIMINARY	DRAWING TITLE	<i>Proposed Elevation 2</i>
			CLIENT		DATE	05 / 04 / 2006
			PROJECT	Bathroom REFURBISHMENT	SCALE	1:20 AT A3
					DRAWING NUMBER	<b>LD0 /DB/008.0</b>
04,04,06	checked / altered	RK				
date	description	initial				